


50

WORK CAL

ALL BOUNDARY

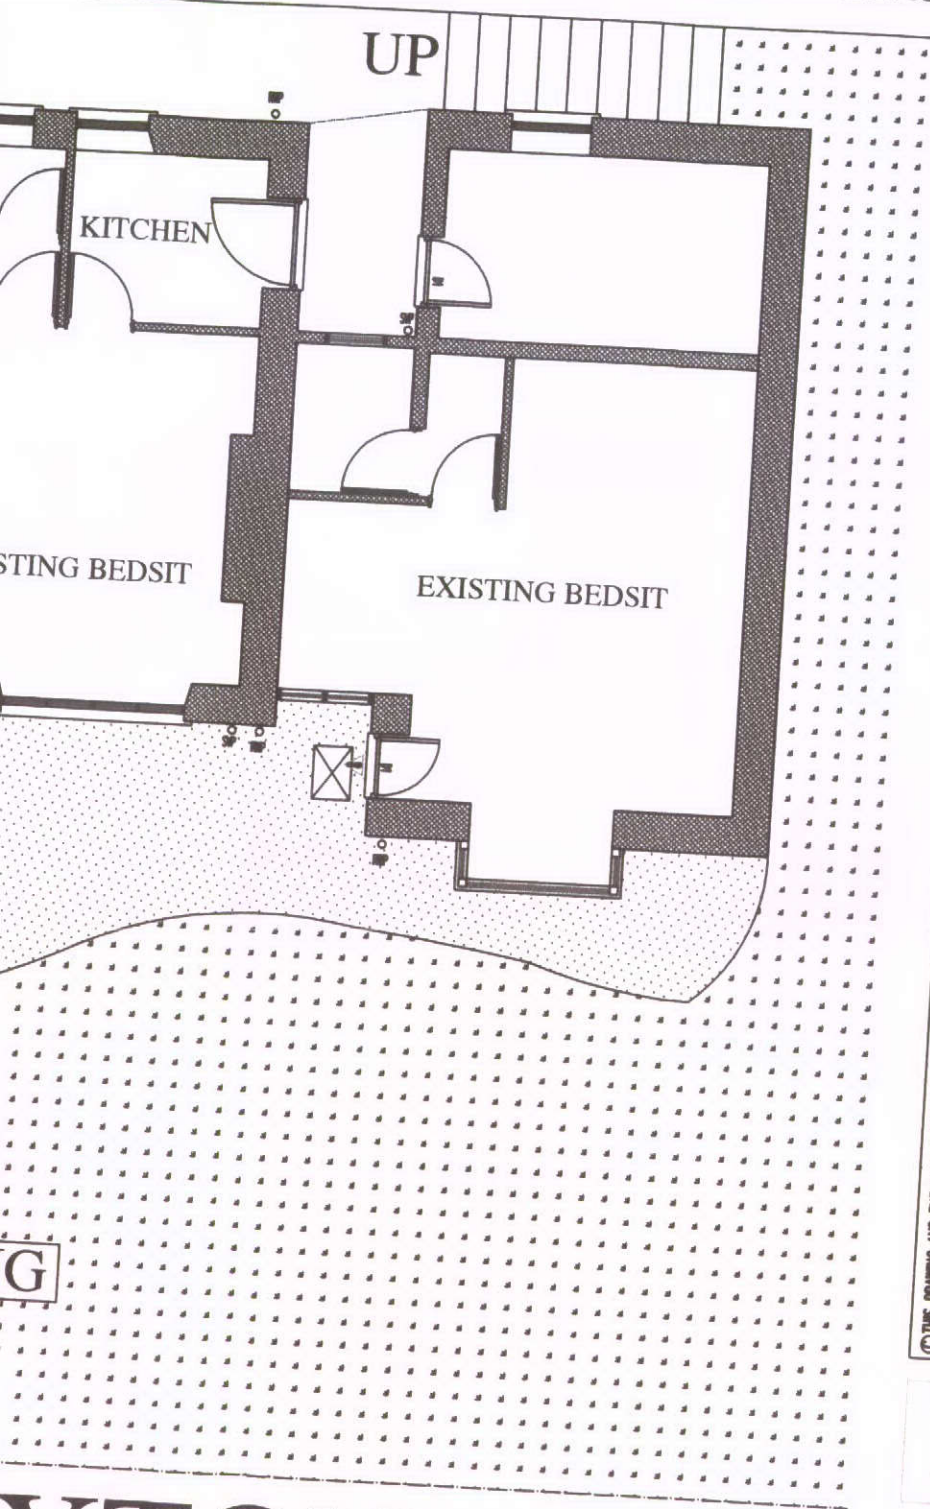

G

XTON

HPK/2010 / 0515

DWG: PROPOSED
13 TERRACE ROAD
TERRACE ROAD, BUXTON

REVISIONS:

1:50	CHECKED:
DATE: SEPT 10	DRAWN:

© THIS DRAWING AND THE BUILDING WORKS DEPICTED ARE THE COPYRIGHT OF AJS ARCHITECTURE AND MAY NOT BE REPRODUCED OR AMENDED EXCEPT BY WRITTEN PERMISSION. NO LIABILITY WILL BE ACCEPTED FOR AMENDMENTS MADE BY OTHER PERSONS. - DO NOT SCALE OFF DRAWING, CONFIRM ALL DIMS ON SITE

A.J.S ARCHITECTURE

32 carr road.
buxton.
derbyshire.
sk17 6wf.

h: 01298 26062
m: 07794 400237

PROPOSED 01
13 TERRACE ROAD


PROPOSED GROUND FLOOR PLAN 1:50

THE EXISTING ALARM SYSTEM IN PLACE WITHIN THE BUILDING OFFERS ADEQUATE DETECTION AND IS APPROVED BY THE FIRE OFFICER. INTERLINKED DETECTION IS PROVIDED ON EACH FLOOR LEVEL AND THIS HAS MAINS BATTERY BACK-UP. EMERGENCY LIGHTING IS IN PLACE THROUGHOUT THE COMMUNAL SPACES WITH FIRE EXTINGUISHERS TO EACH FLOOR LEVEL.

THE NEW DETECTION TO THE PROPOSED FLATS AT FIRST FLOOR LEVEL IS TO BE INTERLINKED INTO THIS SYSTEM AS REQUIRED ON ITS OWN FUSED CIRCUIT. ALL WORK TO BE UNDERTAKEN TO THE APPROVAL OF THE RELEVANT INSPECTOR AND ELECTRICAL CERTIFICATION SUPPLIED FOR ALL WORKS UNDERTAKEN UNDER PART 'P'

PROPOSED DETECTION:

EMERGENCY LIGHTING	EMERGENCY LIGHTING ON FUSED CIRCUIT TO CUT IN ON ELECTRIC POWER FAILURE BS 5266
SD. HD.	INTEGRATED DETECTORS ON MAINS BATTERY BACKUP
CP	MANUAL BREAK GLASS CALL POINTS FOR FIRE ALARM
EXTINGUISHER	FIRE EXTINGUISHER POINTS TO APPROVAL OF FIRE OFFICER
SOUNDER	FIRE ALARM SOUNDER LINKED TO DETECTION
F.D.	FIRE DOOR
ALARM PANEL	CONTROL PANEL FOR APPROVED FIRE ALARM SYSTEM

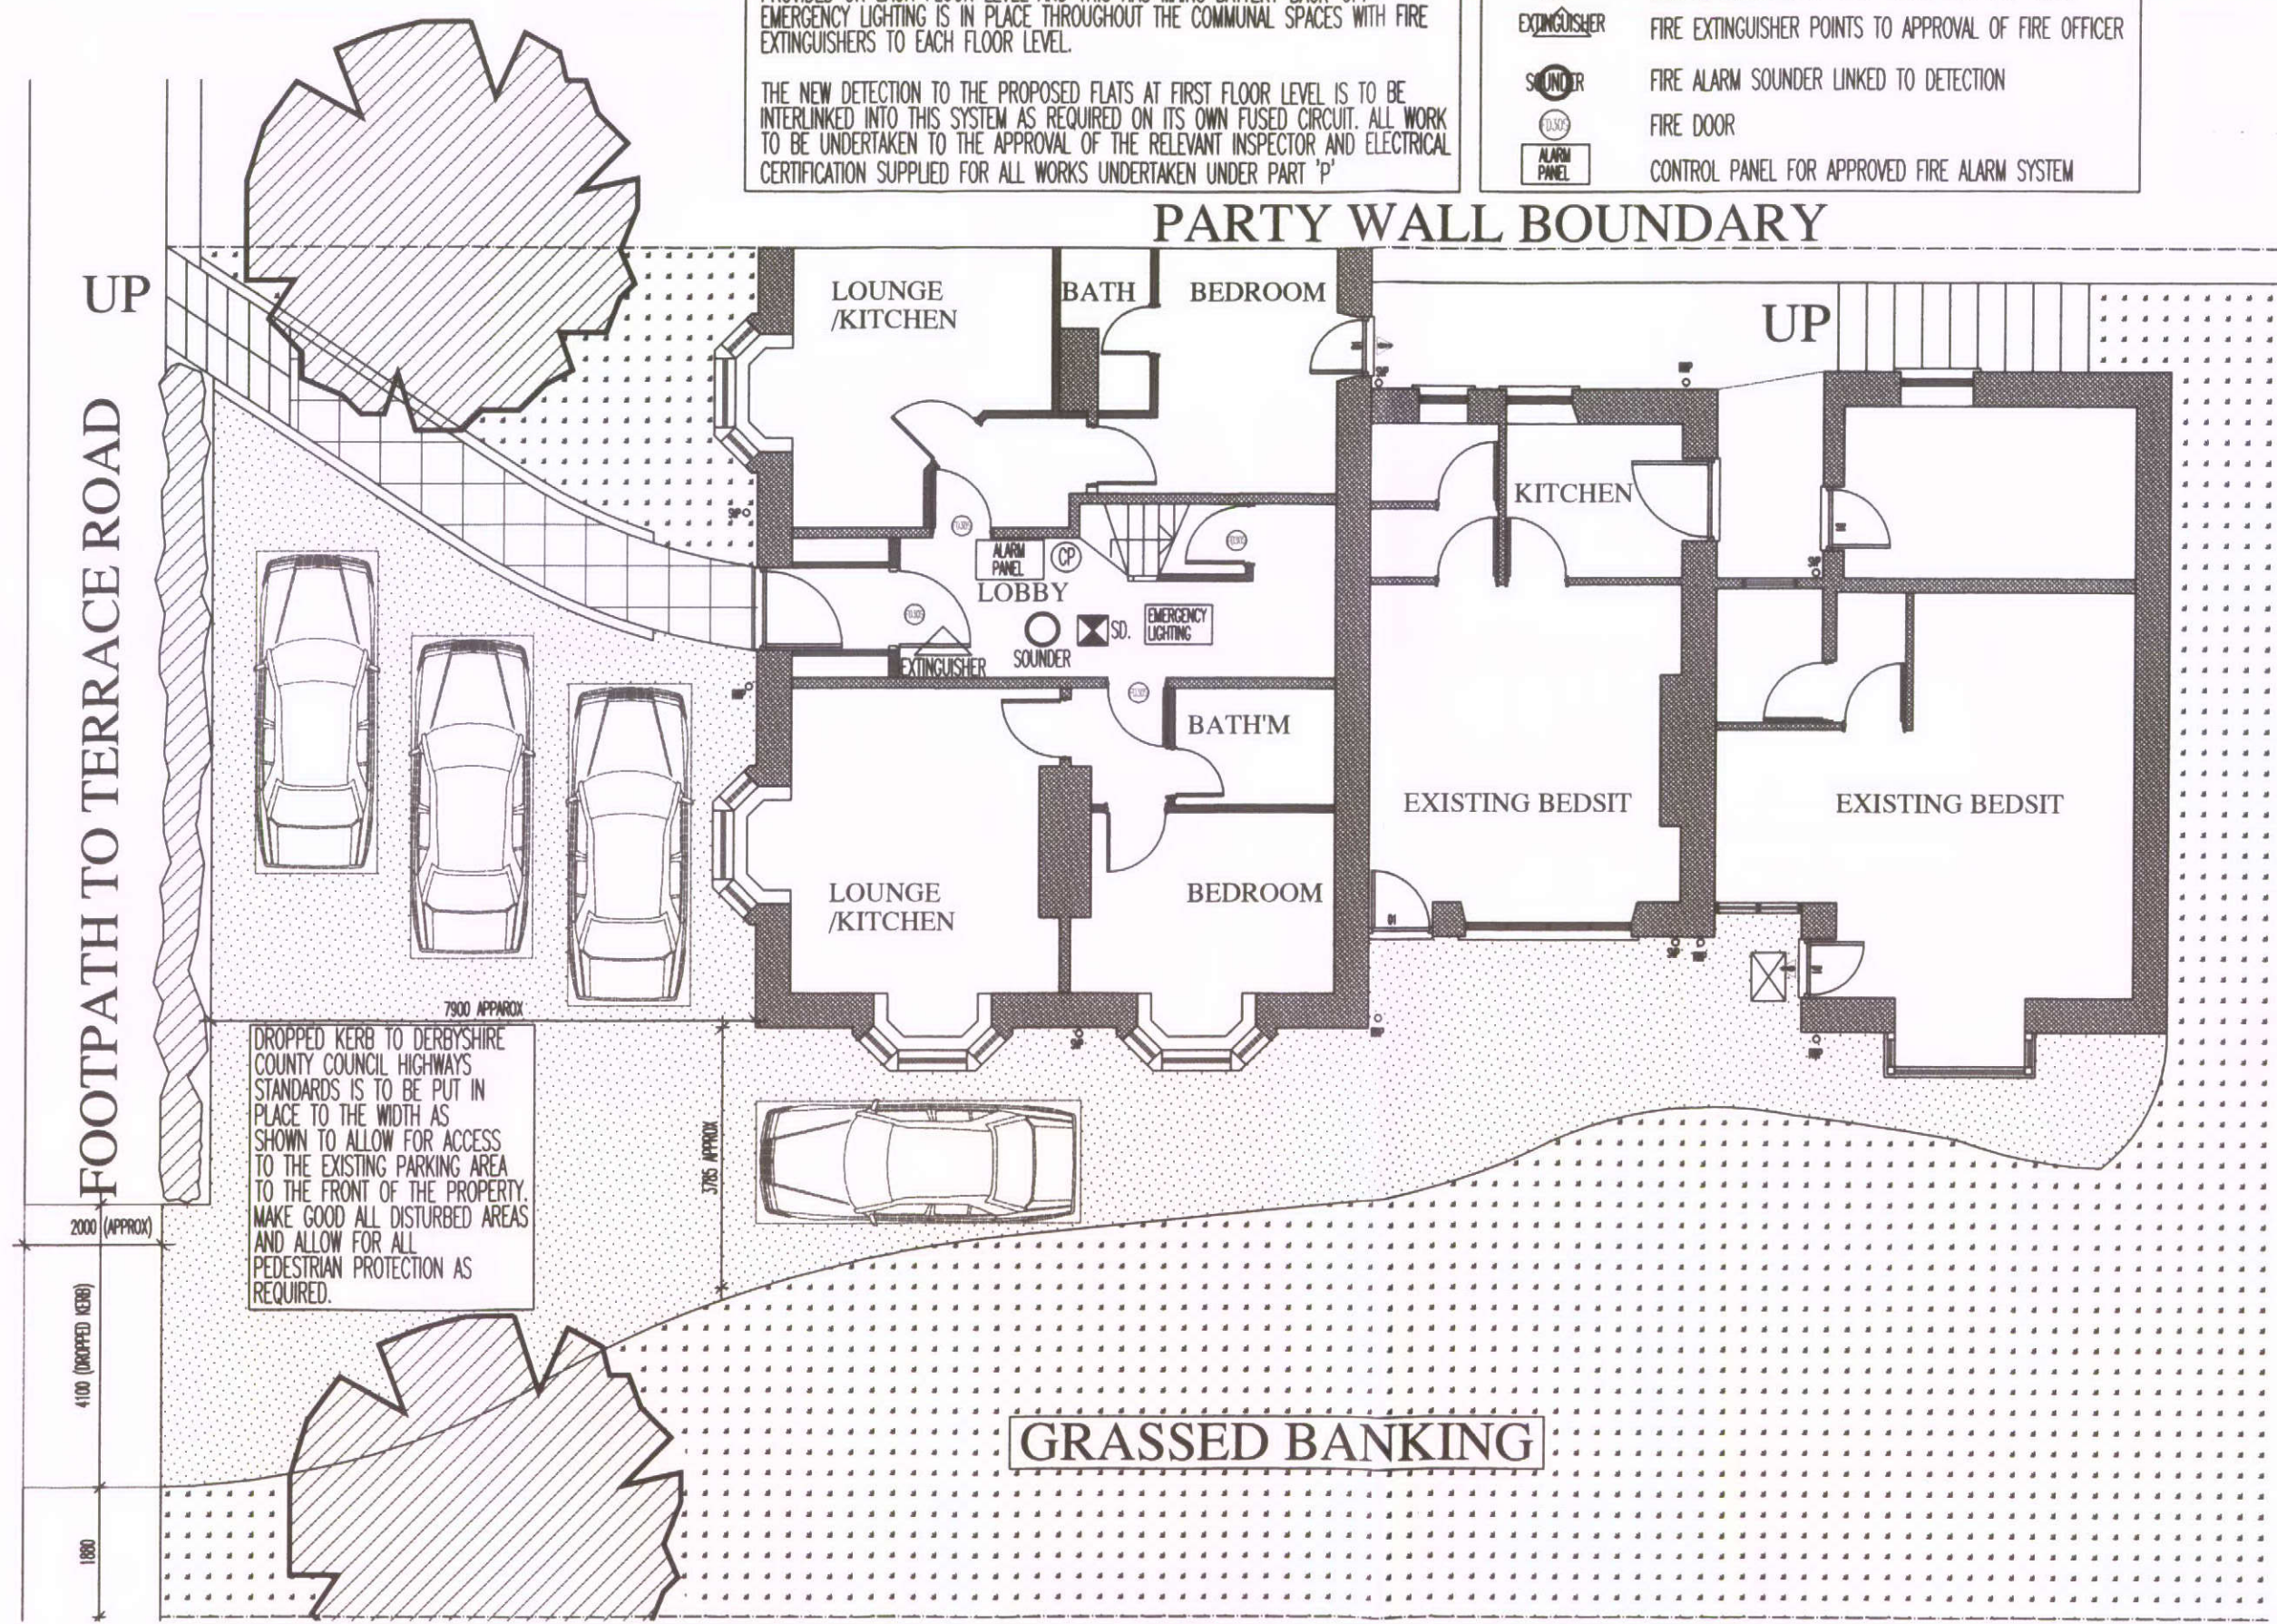

HPK/2010 / 0515

DWG: PROPOSED
13 TERRACE ROAD
TERRACE ROAD, BUXTON

REVISIONS:

1:50
DATE: SEPT 10

CHECKED:
DRAWN:

32 carr road.
buxton.
derbyshire.
sk17 6wf.

h: 01298 26062
m: 07794 400237

A.J.S ARCHITECTURE

©THIS DRAWING AND THE BUILDING WORKS DEPICTED ARE THE COPYRIGHT OF AJS ARCHITECTURE AND MAY NOT BE REPRODUCED OR AMENDED EXCEPT BY WRITTEN PERMISSION. NO LIABILITY WILL BE ACCEPTED FOR AMENDMENTS MADE BY OTHER PERSONS. - DO NOT SCALE OFF DRAWING, CONTENT ALL DIMS ON SITE

13 TERRACE ROAD, BUXTON

PROPOSED 01

13 TERRACE ROAD