



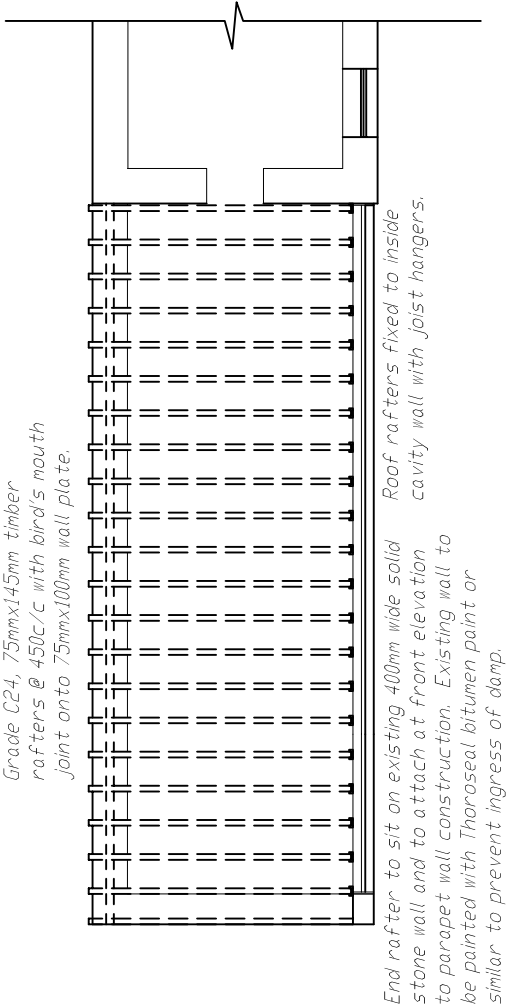

WORKSHOP ROOF PLAN

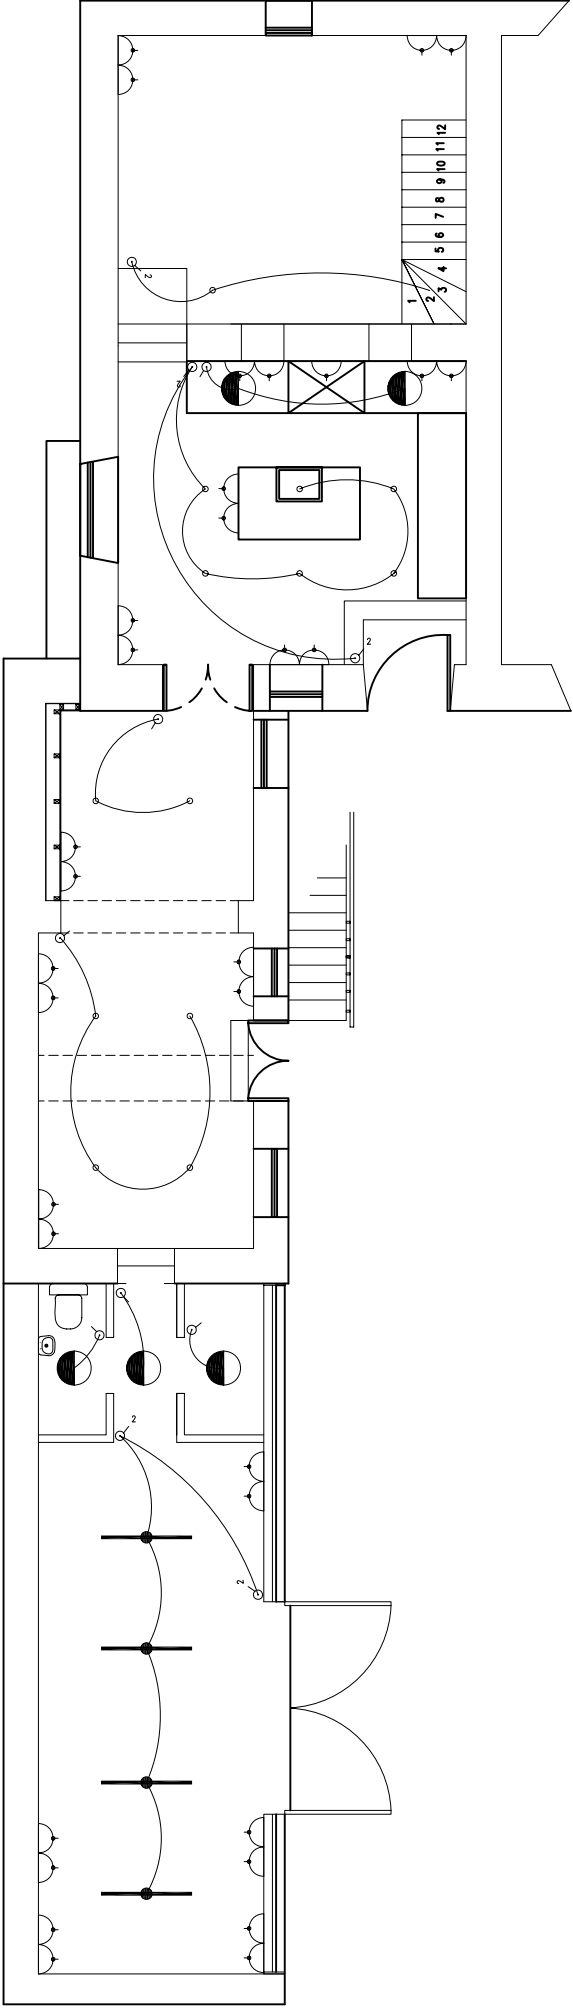

BASEMENT ELECTRICS

NOTES

1. See General Specification for all technical requirements.

KEY

- Wall mounted extract fan
- Flament bulb light fitting
- Fluorescent light fitting
- 2 way light switch
- Single light switch
- TV/satelite/FM socket
- BT socket
- Smoke alarm
- Double switched socket
- Radiator position
- Soil & vent pipe
- Steps in paths.

Rev	Date	Details	By
-----	------	---------	----

Planning Authority	Approval Date	By
--------------------	---------------	----

Building Inspector	Plan Approval Date	By
--------------------	--------------------	----

Do not scale from this drawing. Use written dimensions only. When shown relationships between dimensions, the dimension with the greatest number of significant figures shall govern.

Mark Holmwood & Geraldine Horner

148 Buxton Road
Furness Vale
High Peak
SK23 7PH

Tel: 01663 745114
Tel: 07970 186642
Email: geraldinehorner@necscape.net
Email: markholmwood@necscape.net

SITE
148 Buxton Road
Furness Vale

DRAWING TITLE

Proposed Plans Sheet 2

DRAWN BY	CH	DATE	AUGUST'04	DRAWING NO.	REV
SCALE:	1:500A1	CHECKED/DATE		BRFV-2-100/2	